


NOTE:
 THE ELECTRICAL POINTS ON THIS DRAWING TO BE USED FOR THE POSITIONING THEREOF ONLY, ALL WIRING & CIRCUITRY TO BE TO ELECTRICAL CONSULTANTS DESIGN.
 ALL ELECTRICAL AND LIGHTING EXTERNAL TO THE UNITS TO ELECTRICAL CONSULTANTS DESIGN.

HEIGHTS:
 ALL HEIGHTS ARE TO CENTRE OF POINT.
 ALL PLUGS SHOWN ABOVE KITCHEN COUNTER TO BE 1200 AFFL.
 ALL PLUGS TO APPLIANCES BELOW KITCHEN COUNTER TO BE 500 AFFL.
 FRIDGE PLUG TO BE AT 1200 AFFL.
 ALL PLUGS TO OTHER ROOMS TO BE 500 AFFL UNLESS OTHERWISE NOTED.
 LIGHT SWITCHES TO BE AT 1200 HEIGHT.
 THERMOSTATS TO BE AT 1200 HEIGHT.

ALL SOCKET OUTLETS & LIGHT FITTINGS SHOWN EXTERNALLY TO BE WATERPROOF.

ELECTRICAL LEGEND

- ELECTRICAL DISTRIBUTION BOARD
- CEILING MOUNTED LUMINAIRE
- WALL MOUNTED LUMINAIRE
- UNDER CUPBOARD LIGHTING
- FLOURESCENT LIGHT
- LV DOWNLIGHTS
- EXTRACT FAN
- SWITCHED WITH LIGHT
- ONE WAY SWITCH
- TWO WAY SWITCH
- DIMMER SWITCH
- TELKOM / INTERCOM OUTLET
- INTERNET OUTLET
- UNWIRED OUTLET FOR POSSIBLE TELKOM / INTERCOM OR INTERNET WIRING
- SPEAKER POINT
- U/FLOOR HEATING THERMOSTAT
- 16A SOCKET OUTLET
- 16A DOUBLE SOCKET OUTLET
- UNWIRED DRAWBOX FOR POSSIBLE AC UNIT
- SHAVER POINT
- OVEN & HOB ISOLATOR
- OVEN & HOB POWER POINT
- TV OUTLET
- WALL HEATER
- UNWIRED OUTLET FOR POSSIBLE HEATED TOWEL RAIL
- CEILING FAN
- SMOKE DETECTOR
- HEAT DETECTOR
- BELL PUSH
- BELL SOUNDER

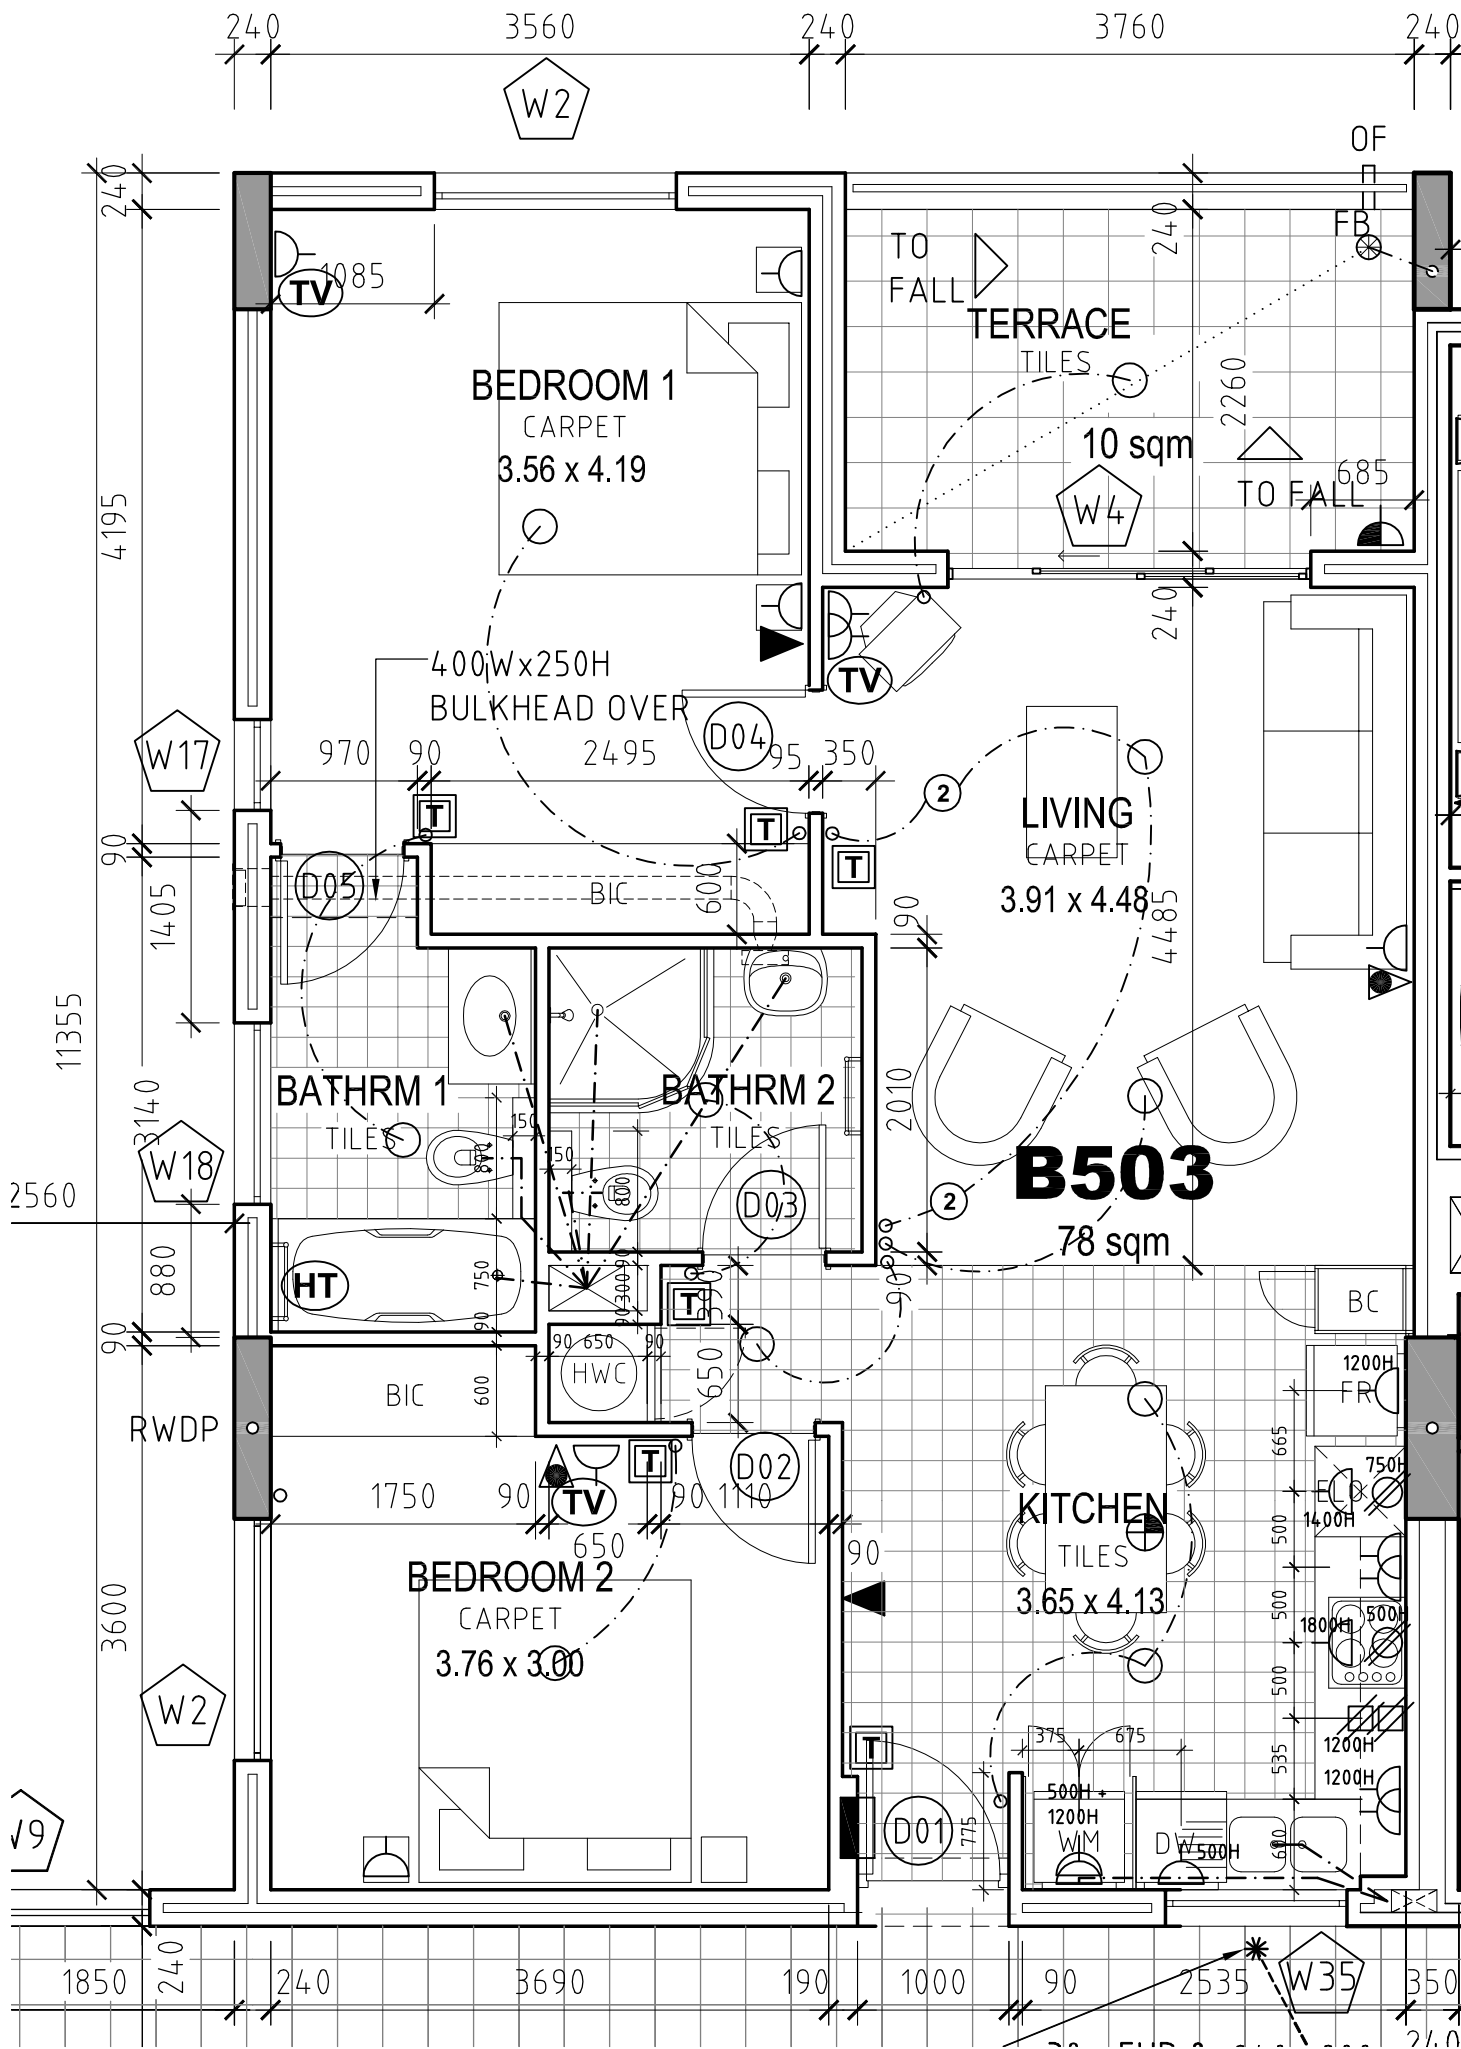

rev	date	description
B	28.11.2006	MECHANICAL VENTILATION ADDED
A	25.09.2006	KITCHEN PLUG POSITIONS REVISED, BICS DIMENSIONED

architect
MARC HARRIES ARCHITECTS
 UNIT 1 ROELAND SQUARE
 ROELAND STREET
 CAPE TOWN
 TEL 021 465 2233 FAX 021 465 2220

drawing title
PALM GROVE
 UNIT 503
 DIMENSIONED LAYOUT PLAN

project OASIS		
scale	date	rev.
1:50	19 JUNE 2005	B